

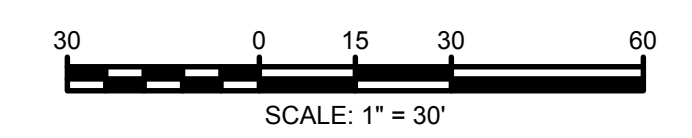


Estimated Time-frame: August 5th to January 17th 2024


 


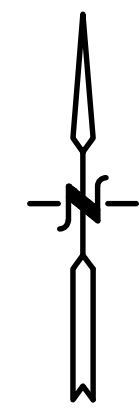

 
 

 

 


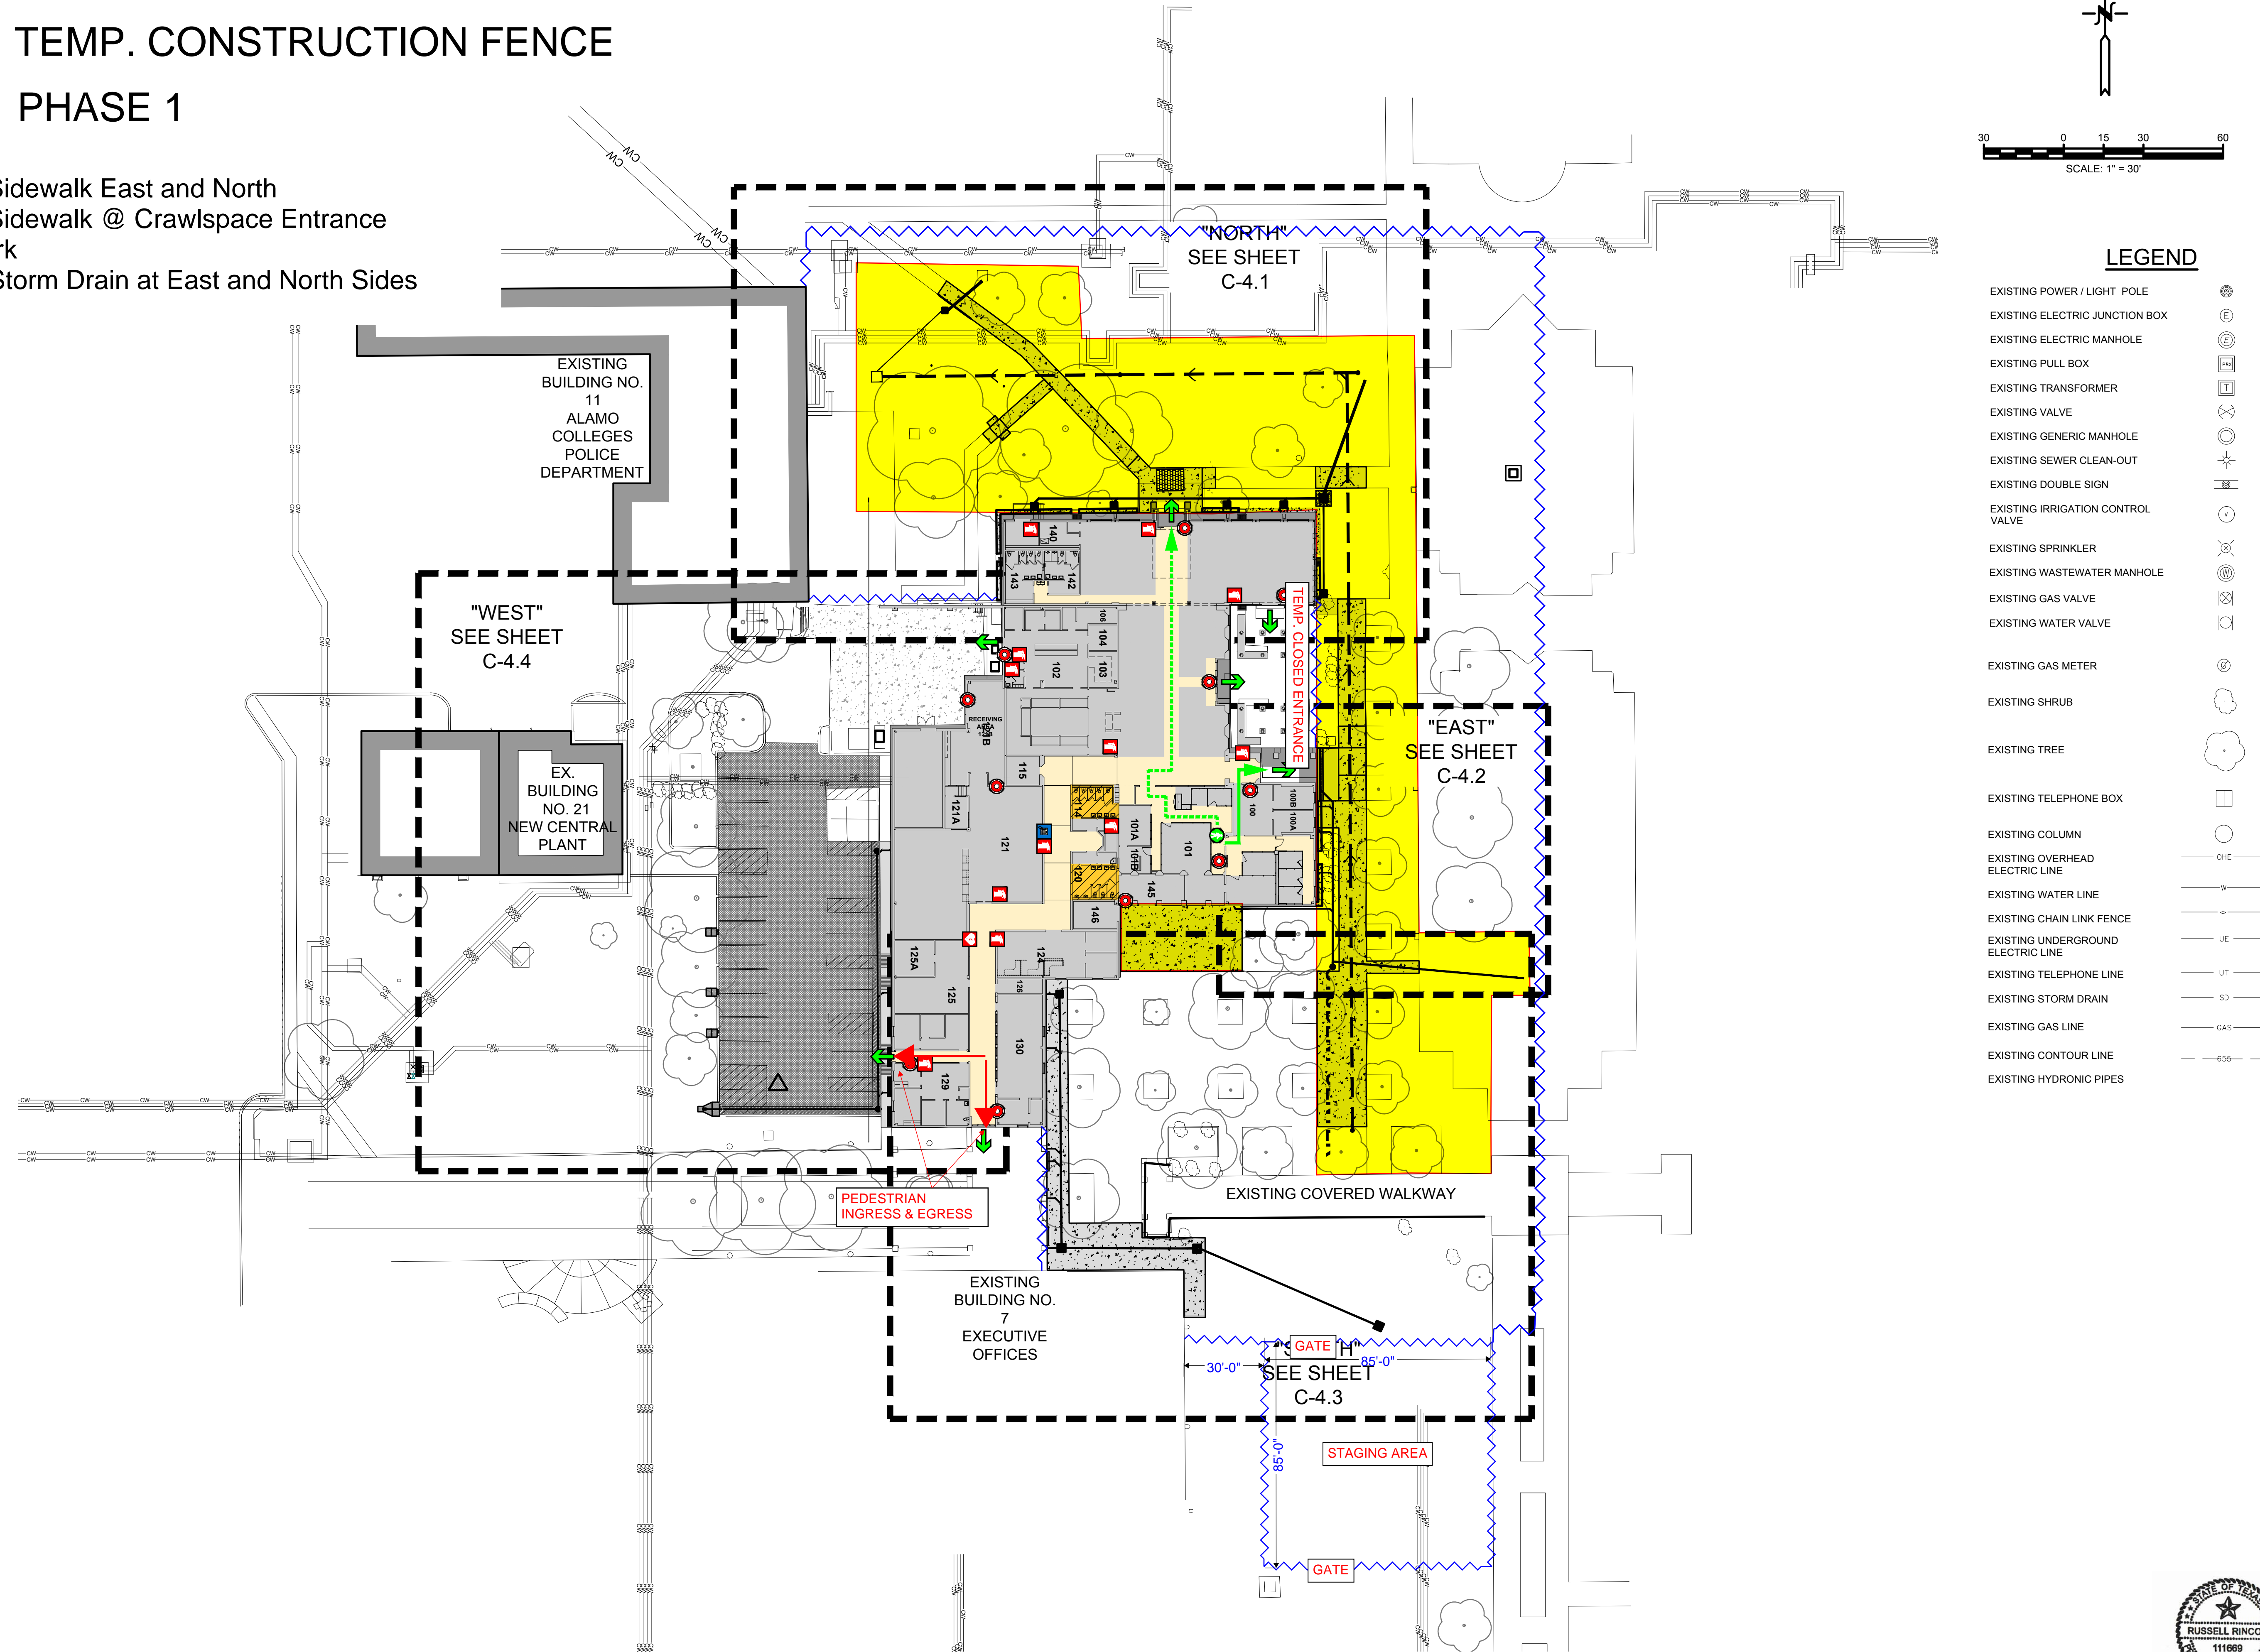






 


 


 
 TEMP. CONSTRUCTION FENCE

 PHASE 1

- Demolition of Sidewalk East and North
- Demolition of Sidewalk @ Crawspace Entrance
- Underfloor Work
- Installation of Storm Drain at East and North Sides



LEGEND

- EXISTING POWER / LIGHT POLE 
- EXISTING ELECTRIC JUNCTION BOX 
- EXISTING ELECTRIC MANHOLE 
- EXISTING PULL BOX 
- EXISTING TRANSFORMER 
- EXISTING VALVE 
- EXISTING GENERIC MANHOLE 
- EXISTING SEWER CLEAN-OUT 
- EXISTING DOUBLE SIGN 
- EXISTING IRRIGATION CONTROL VALVE 
- EXISTING SPRINKLER 
- EXISTING WASTEWATER MANHOLE 
- EXISTING GAS VALVE 
- EXISTING WATER VALVE 
- EXISTING GAS METER 
- EXISTING SHRUB 
- EXISTING TREE 
- EXISTING TELEPHONE BOX 
- EXISTING COLUMN 
- EXISTING OVERHEAD ELECTRIC LINE 
- EXISTING WATER LINE 
- EXISTING CHAIN LINK FENCE 
- EXISTING UNDERGROUND ELECTRIC LINE 
- EXISTING TELEPHONE LINE 
- EXISTING STORM DRAIN 
- EXISTING GAS LINE 
- EXISTING CONTOUR LINE 
- EXISTING HYDRONIC PIPES 

REVISIONS:	
SHEET TITLE OVERALL GRADING PLAN	
DATE 04/12/24	DRAWN BY RG
PROJECT NUMBER C-1480.46	SHEET NUMBER C-4.0



RJR
 04/12/2023




Date: Apr 11, 2024, 4:30pm, User: R. Rincon, File: W:\Users\Rinco\Documents\Projects\C-1480.46\EXT GRADING PLAN OVERALL.dwg

Estimated Time-frame: January 17th, 2024 to April 03rd, 2025

 TEMP. CONSTRUCTION FENCE

 PHASE 2

- Demolition of Flatwork at South Side
- Installation of Storm Drain at South Side
- Installation of Flatwork at North, East and South

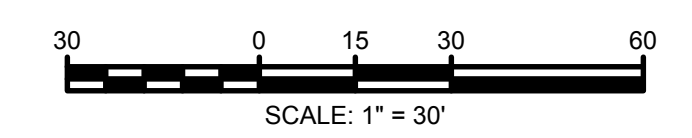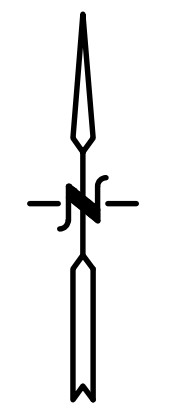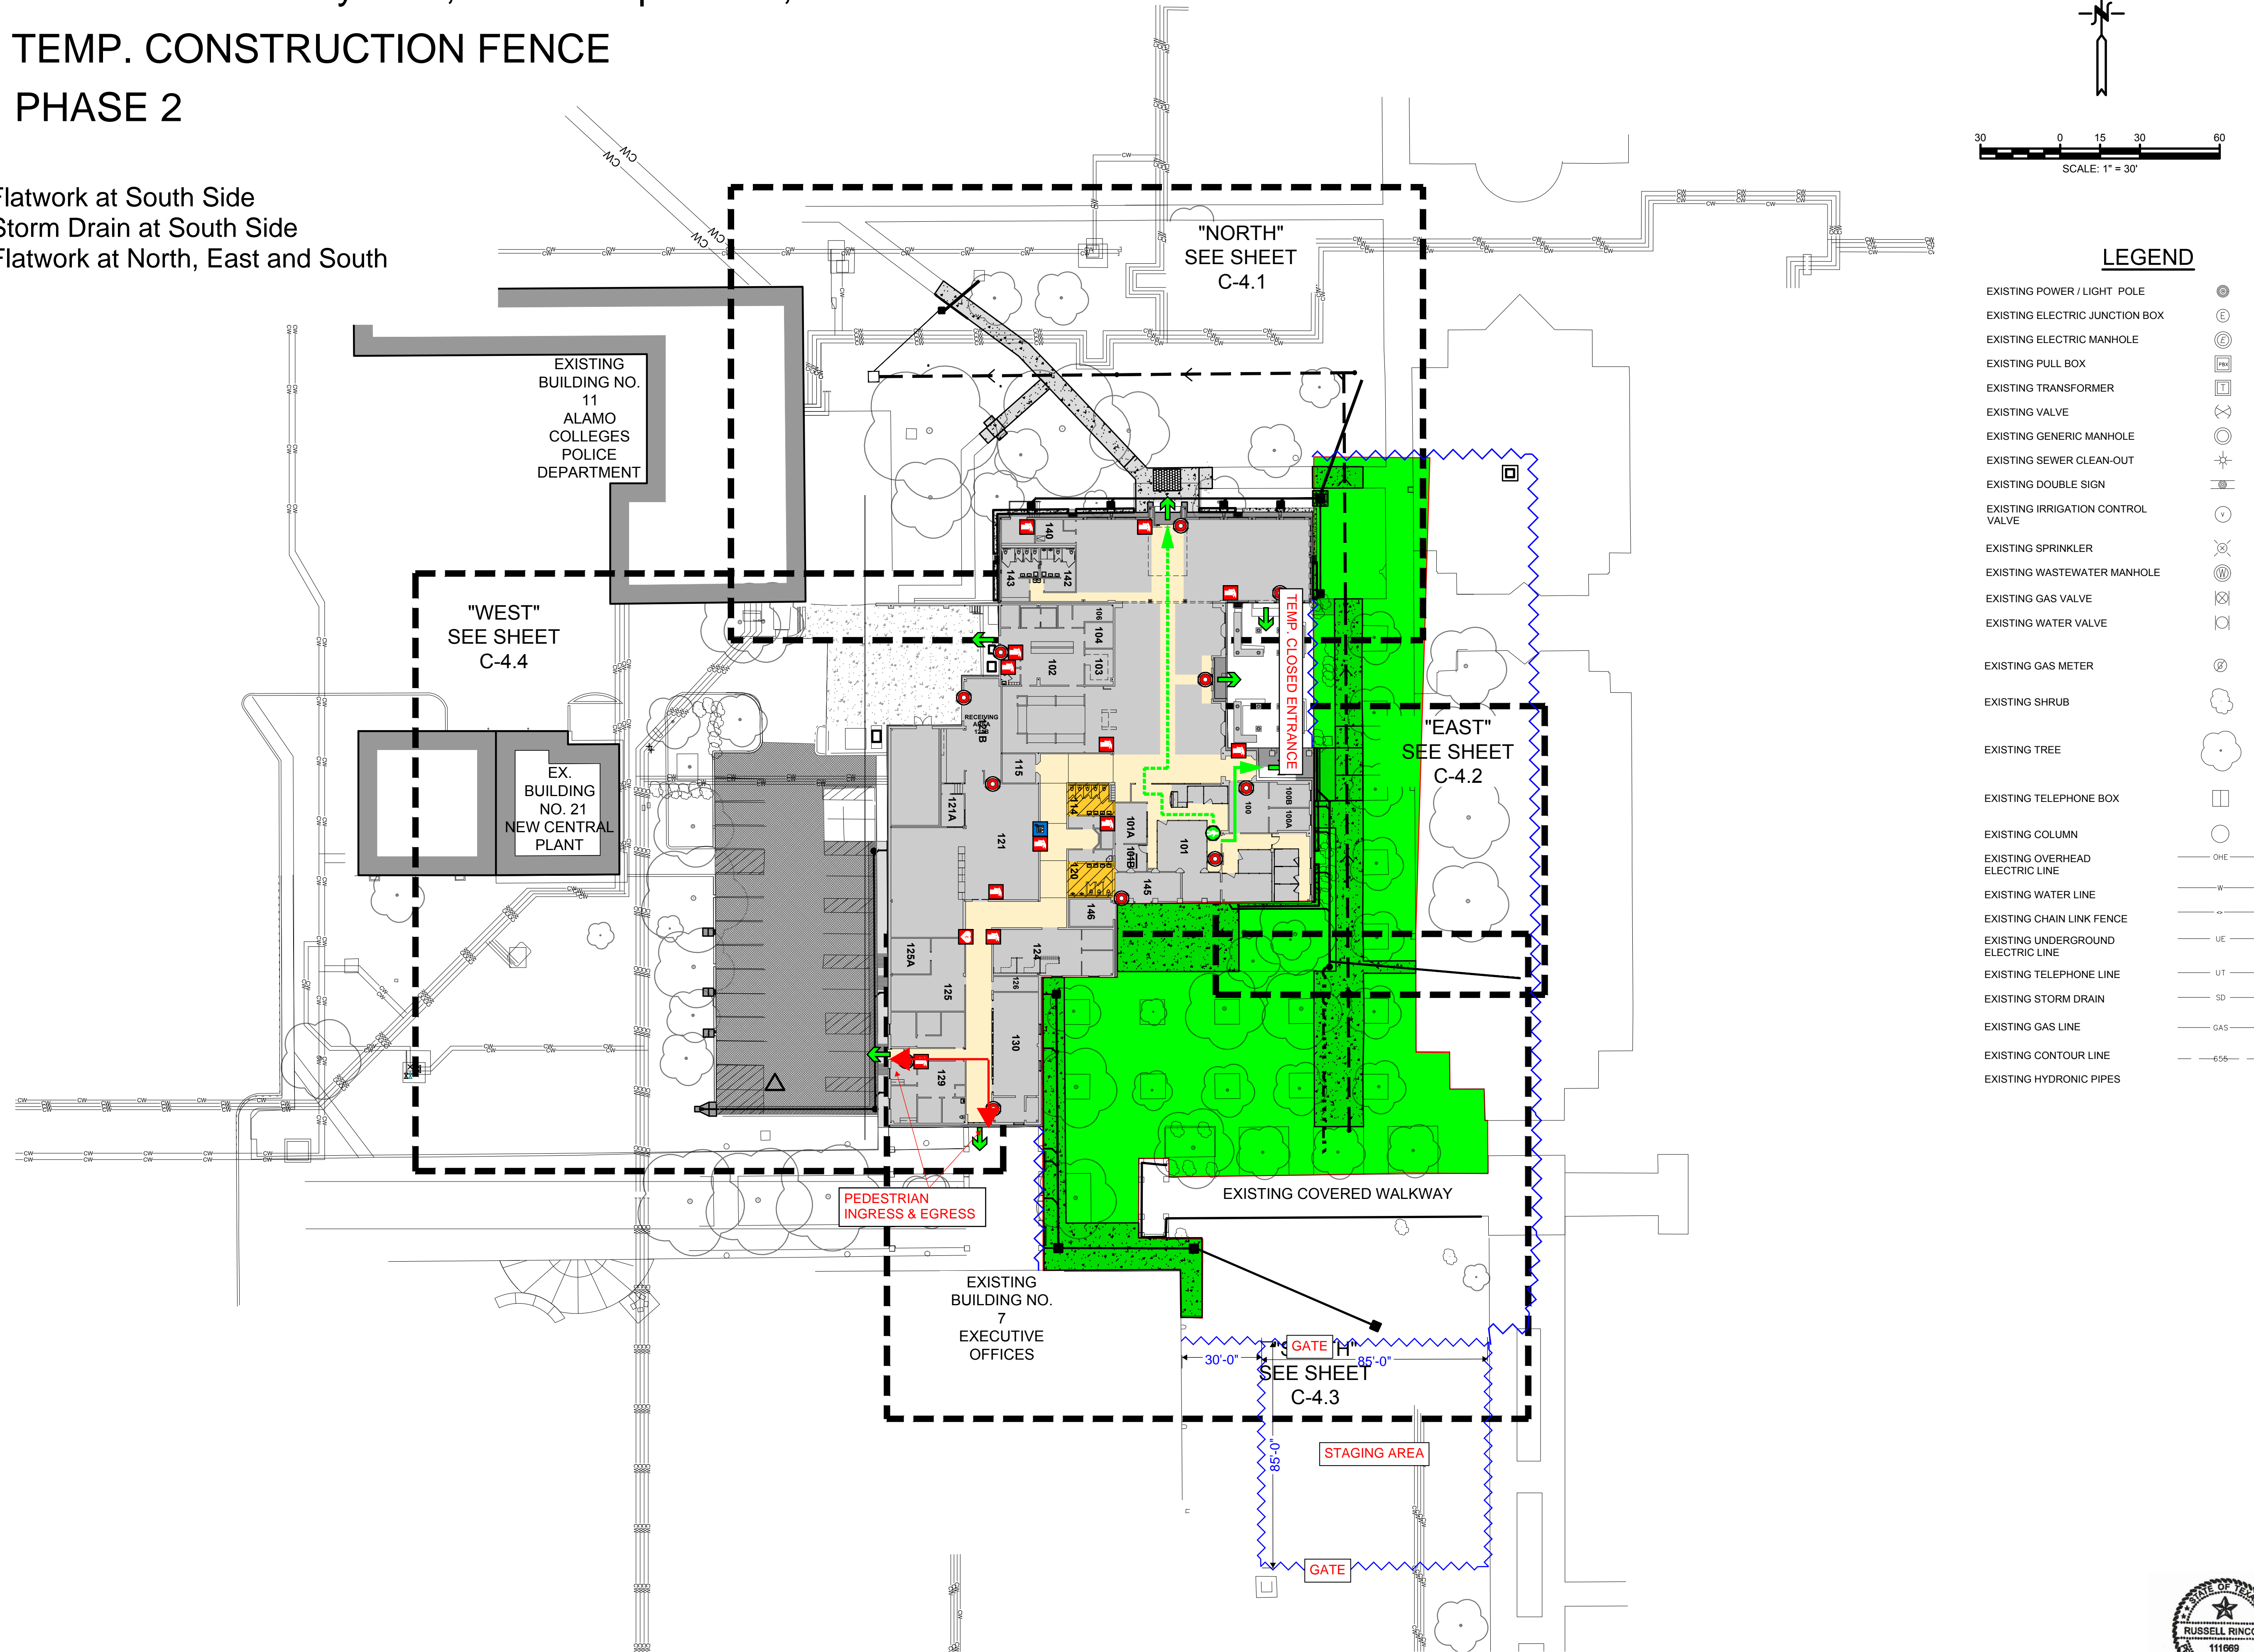

LEGEND

- EXISTING POWER / LIGHT POLE
- EXISTING ELECTRIC JUNCTION BOX
- EXISTING ELECTRIC MANHOLE
- EXISTING PULL BOX
- EXISTING TRANSFORMER
- EXISTING VALVE
- EXISTING GENERIC MANHOLE
- EXISTING SEWER CLEAN-OUT
- EXISTING DOUBLE SIGN
- EXISTING IRRIGATION CONTROL VALVE
- EXISTING SPRINKLER
- EXISTING WASTEWATER MANHOLE
- EXISTING GAS VALVE
- EXISTING WATER VALVE
- EXISTING GAS METER
- EXISTING SHRUB
- EXISTING TREE
- EXISTING TELEPHONE BOX
- EXISTING COLUMN
- EXISTING OVERHEAD ELECTRIC LINE
- EXISTING WATER LINE
- EXISTING CHAIN LINK FENCE
- EXISTING UNDERGROUND ELECTRIC LINE
- EXISTING TELEPHONE LINE
- EXISTING STORM DRAIN
- EXISTING GAS LINE
- EXISTING CONTOUR LINE
- EXISTING HYDRONIC PIPES

ALAMO COLLEGES
2221 N. Alamo St.
San Antonio, TX 78213



PREPARED BY:
BAIN MEDINA BAIN, INC.
ENGINEERS & SURVEYORS
7079 San Pedro Avenue
San Antonio, Texas 78216
210/494-7529
TBEPL Registration No. F-1712
TBEPLS Registration No. 10020900



ALAMO COLLEGES
PALO ALTO COLLEGE
STUDENT CENTER
EXTERIOR & UNDERFLOOR IMPROVEMENTS
SAN ANTONIO, TEXAS
PROJECT NUMBER: C-1480.46

REVISIONS:

SHEET TITLE
OVERALL GRADING PLAN

DATE: 04/12/24
PROJECT NUMBER: C-1480.46
DRAWN BY: RG
SHEET NUMBER:

C-4.0



RJR
04/12/2023


Date: Apr 11, 2024, 10:29am, User: R. Rincon, File: W:\Users\Rinco\Documents\Projects\C-1480.46\EXT GRADING PLAN OVERALL.dwg

Estimated Time-frame: January 17th to March 05th, 2025

 TEMP. CONSTRUCTION FENCE

 PHASE 3

- Demolition of Flatwork and Curb
- Installation of Storm Drain at West Side
- Installation of Flatwork

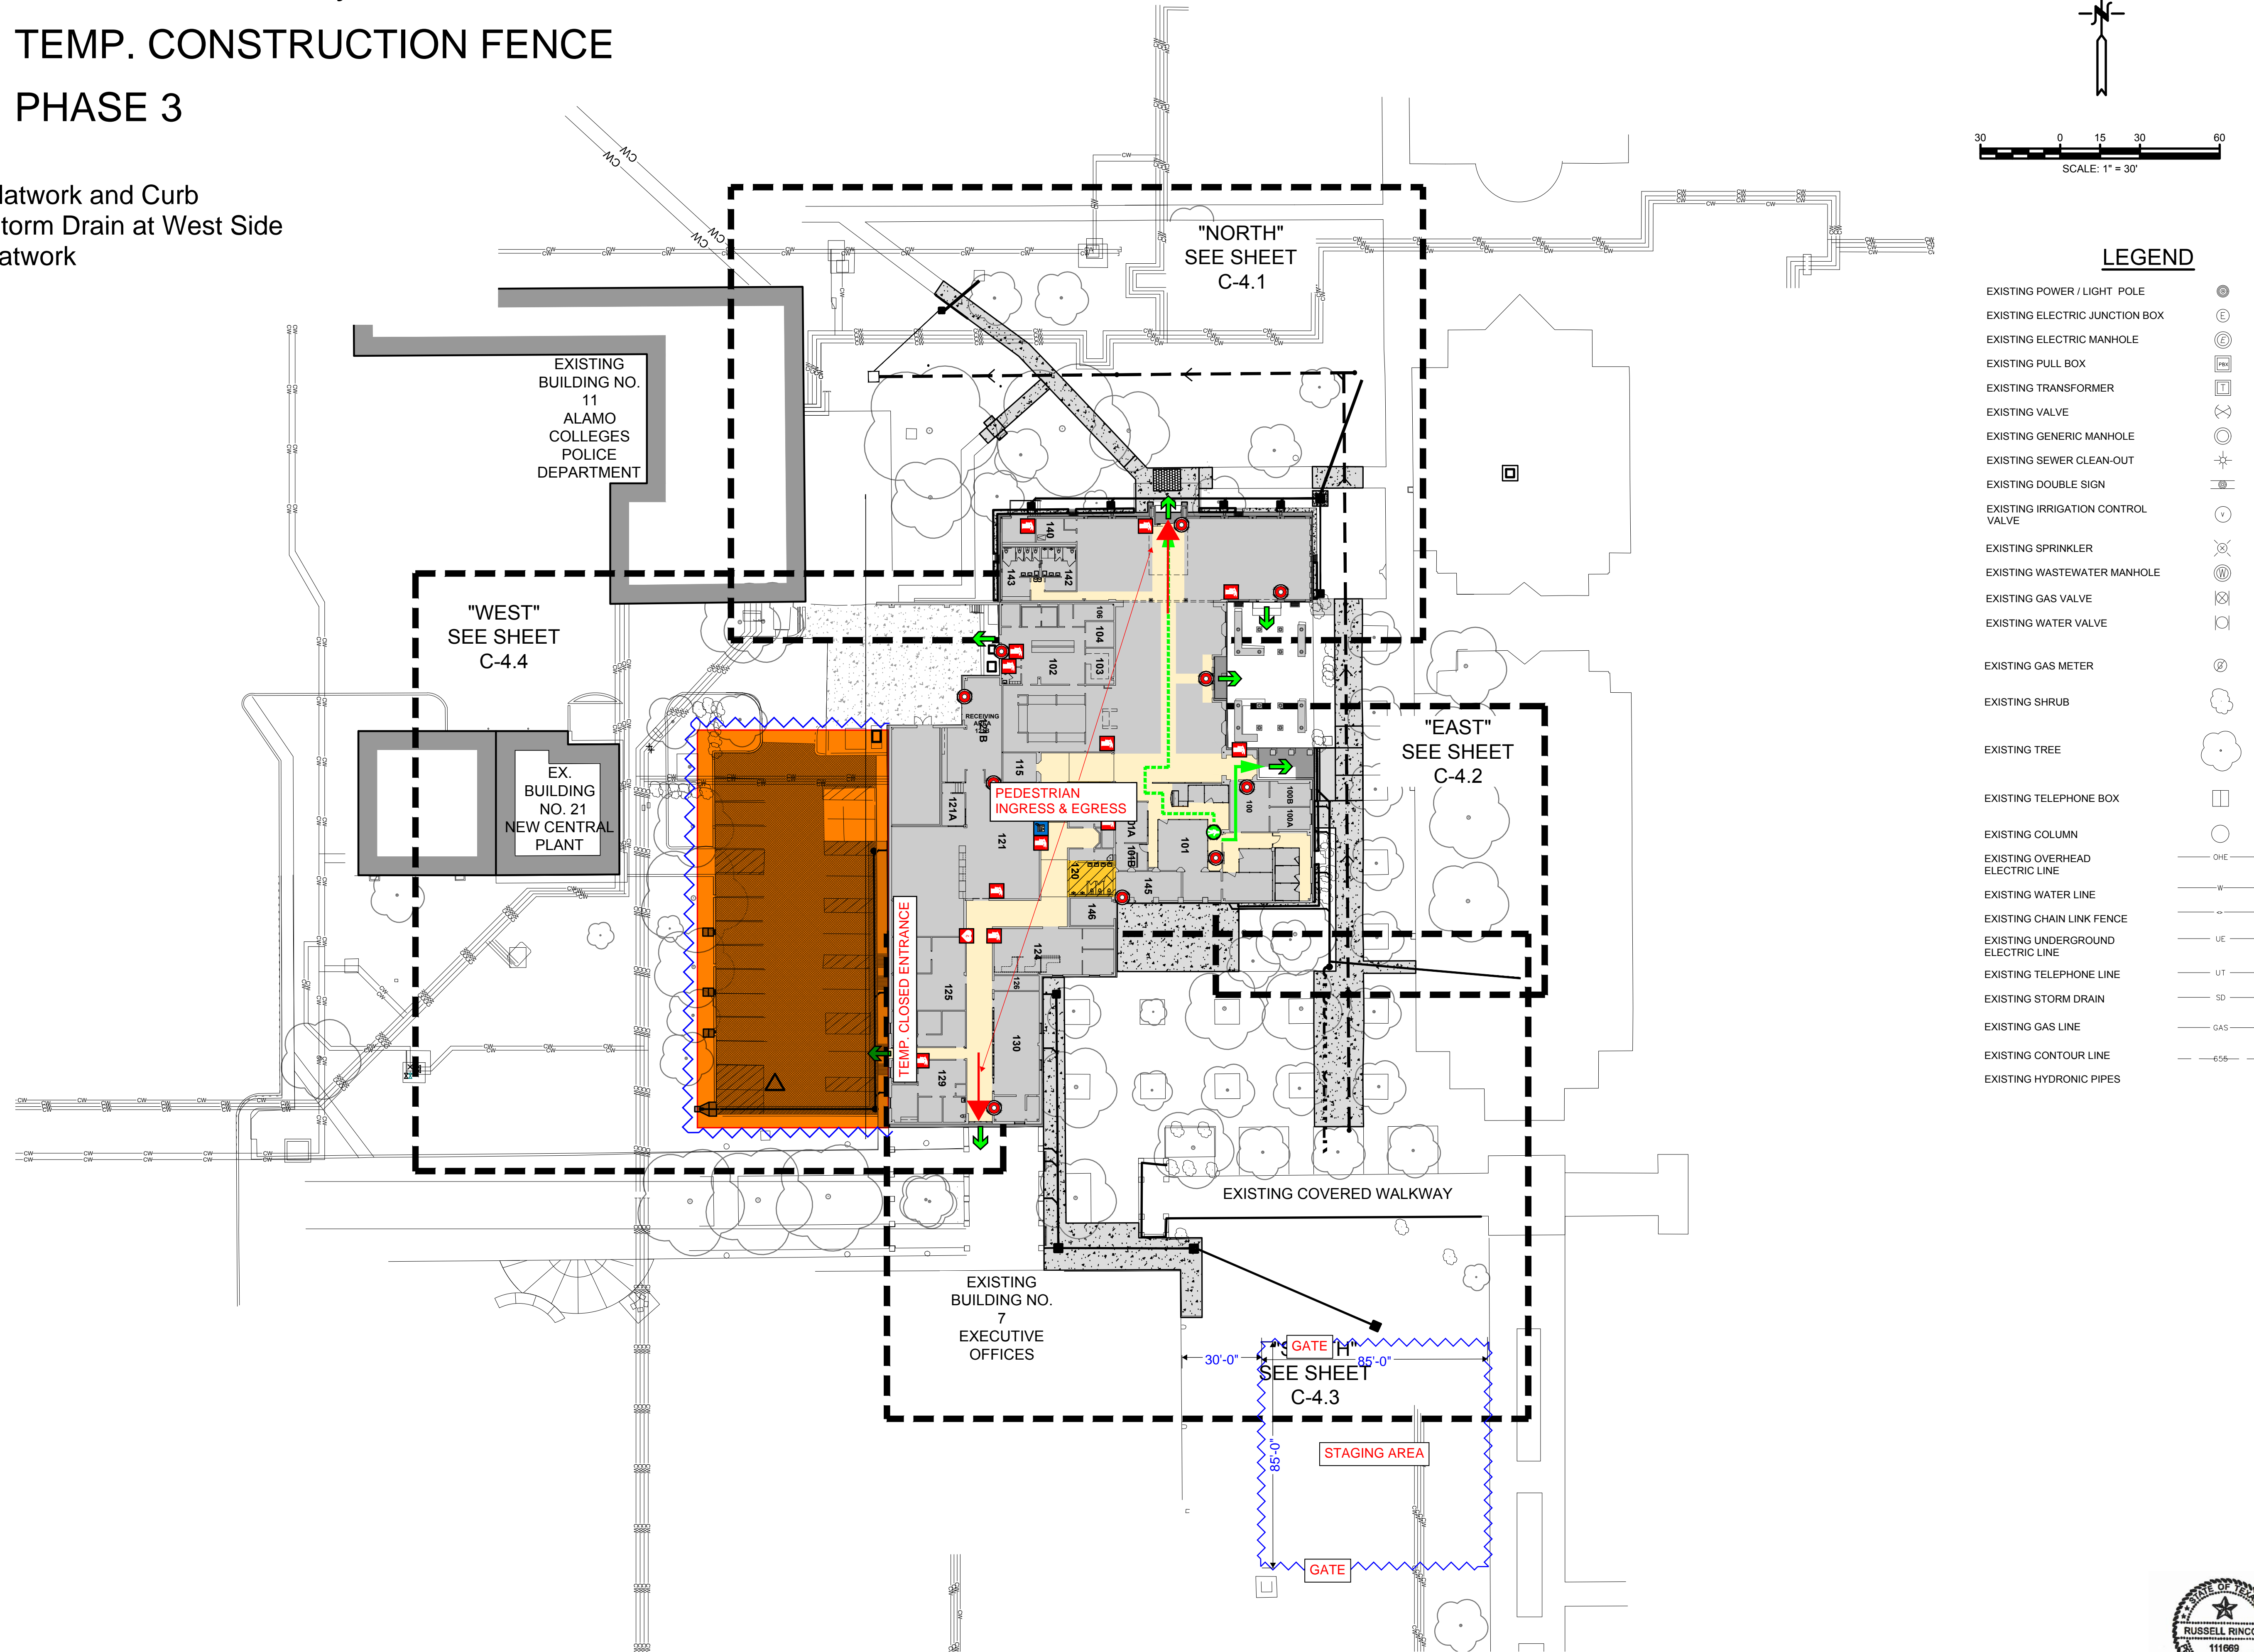

LEGEND

- EXISTING POWER / LIGHT POLE
- EXISTING ELECTRIC JUNCTION BOX
- EXISTING ELECTRIC MANHOLE
- EXISTING PULL BOX
- EXISTING TRANSFORMER
- EXISTING VALVE
- EXISTING GENERIC MANHOLE
- EXISTING SEWER CLEAN-OUT
- EXISTING DOUBLE SIGN
- EXISTING IRRIGATION CONTROL VALVE
- EXISTING SPRINKLER
- EXISTING WASTEWATER MANHOLE
- EXISTING GAS VALVE
- EXISTING WATER VALVE
- EXISTING GAS METER
- EXISTING SHRUB
- EXISTING TREE
- EXISTING TELEPHONE BOX
- EXISTING COLUMN
- EXISTING OVERHEAD ELECTRIC LINE
- EXISTING WATER LINE
- EXISTING CHAIN LINK FENCE
- EXISTING UNDERGROUND ELECTRIC LINE
- EXISTING TELEPHONE LINE
- EXISTING STORM DRAIN
- EXISTING GAS LINE
- EXISTING CONTOUR LINE
- EXISTING HYDRONIC PIPES

ALAMO COLLEGES
2231 N. Alamo St.
San Antonio, TX 78213

PREPARED BY:
BAIN MEDINA BAIN, INC.
ENGINEERS & SURVEYORS
7079 San Pedro Avenue
San Antonio, Texas 78216
210/494-7229
TBEPL Registration No. F-1712
TBEPLS Registration No. 10020900

ALAMO COLLEGES
PALO ALTO COLLEGE
STUDENT CENTER
EXTERIOR & UNDERFLOOR IMPROVEMENTS
SAN ANTONIO, TEXAS
PROJECT NUMBER: C-1480.46

REVISIONS:	
SHEET TITLE	
OVERALL GRADING PLAN	
DATE	04/12/24
PROJECT NUMBER	C-1480.46
DRAWN BY	RG
SHEET NUMBER	



RJR
04/12/2023

C-4.0

Date: Apr 11, 2024, 10:29am, User: R. Rincon, File: W:\Users\Rinco\Projects\Construction Documents\C-1480.46\EXT GRADING PLAN OVERALL.dwg